


- 1 KSA 889 A1
- 2 HFBW1B-T61
- 3 HKB60KM-RK2
- 4 UG60LGSV
- 5 HFBW1B-T61
- 6 XU45RK
- 7 XUS60
- 8 XU45RK
- 9 UEFL10
- 10 XU80LRK
- 11 XU80LRK
- 12 XU30LRKFFIL
- 13 USVK1B-T80
- 14 U6035
- 15 U6035
- 16 U6035
- 17 U6035
- 18 OX120FKBALU
- 18.1 AP-LED8BO120
- 21 XUE100SB
- 22 AR120ROLALU
- 23 OX120FKBALU
- 23.1 AP-LED8BO120
- 24 UBL20
- 25 TT 5486 N
- 26 AK60GS
- 27 OSVK1B-T40
- 28 OSVK1B-T40
- 29 ABL10
- 31 NRW1B
- 32 OFBW1B-T40
- 33 OCSR90

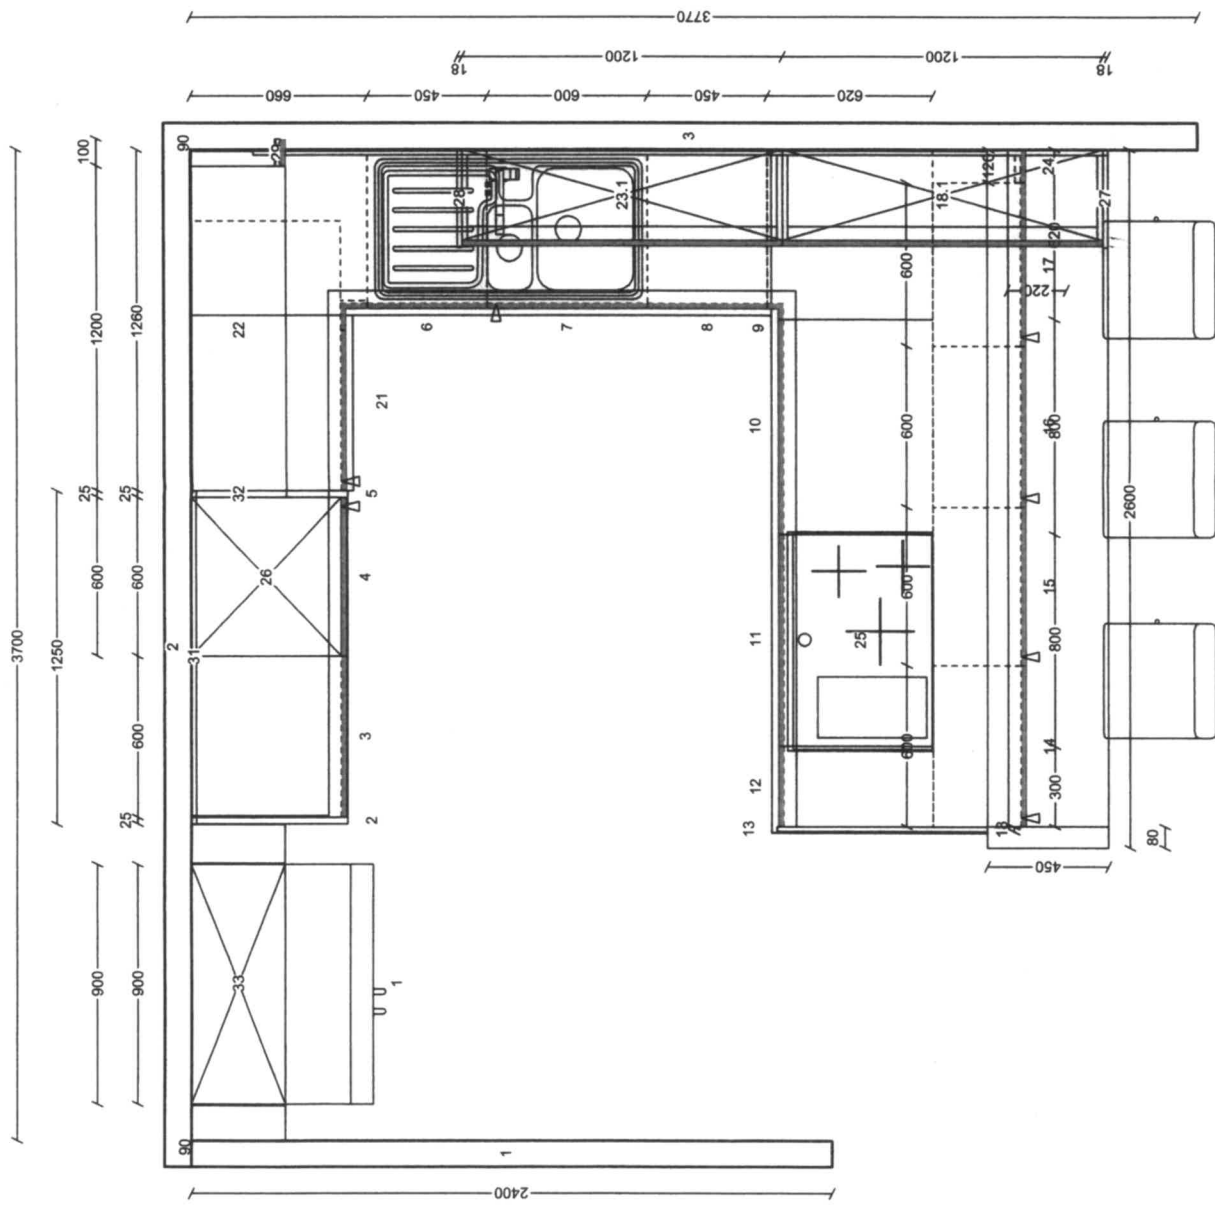

Bestellung EWE



**eilmannsberger**

Eilmannsberger GmbH  
Scheiblb. 50  
4150 Rohrbach

Grundriss  
Kommission 1001/4

Maßstab 1:20

Eilmannsberger  
Rohrbach

**EWE Nuovd**

9801

CARAT, V2014.5.3.0, #111633